




Pool & Spa Details

Installation by National Pools
 40' x 14' Pool, Inside Coping
 Top of Pool Back Wall to be +2'-5" from B.M.
 Pool Wall to be made from 8" CMU
 Pool to have 7" Wide Sun Shelf
 (3) 24" Wide Weirs- Location TBD
 Weirs: 1 Gallon/Inch/Minute
 Weirs to Have Fiber Optic Lighting
 7' x 7' Spa, Inside Coping
 Spa Wall to be 1" Veneer TBD
 15" Capstone (1" Overhang)
 Spa to have 10" Step for Entry
 Spa to be +18" above Decking

- Pool & Weirs - See Details List
- Spa - See Details List
- 1/4"-8" Silt Drain (Vector Drain 2305VEC)
- 1/6 x 1/6 Cabana w/ 18" wide Stone Column
- (1) Fan & (4) Can Lights
- Bar Counter with 3/8" Grill - See Details
- Metal Round Drain
- (2) Electrical Circuits Under Cabinets
- (2) Electrical Outlets on Cabinets
- (4) Hardscape Lights # Under Column Cap
- PA Bluestone Patio w/ 6" Paver Border
- 15" BlueSelect Color, Random Pattern
- Concrete Base
- Rectangular Section above Steps set at 45% d
- Blu45 6.5"x13" Paver Border, Sandwood Color
- 5.5 (32ct flat) Purple Periwinkle
- 6 Cassian Fountain Grass
- B Justin Browsers Boxwood

Backyard Lighting Plan

- (4) at Cabana Column, Hardscape Copper Light #4260
- (2) at Fire Bowl Columns, Copper Hardscape Light #4260
- (3) at Pool Retaining Wall, Copper Hardscape Light #4260
- (17) at Ex. Wall & Step, Hardscape Copper Light #4260
- (9) Copper Path Light #2126

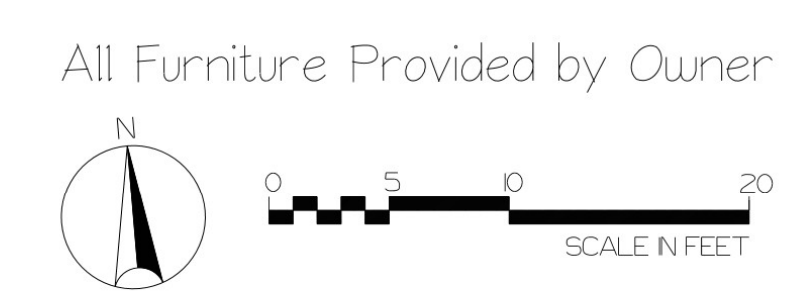

NOTES

This design is the sole property of SLG, Inc. The distribution, reproduction, or use of this design is strictly prohibited unless written authorization has been received by SLG, Inc. or one of its agents. Violation of copyright law is punishable by fines up to \$2,500.

No.	Date	Description

Moon Williams Rd Residence
 Backyard Pool

Jackie & Bobby Moon
 4416 Williams Rd
 Lynchburg, VA 24503

SCALE: 1/8" = 1'-0"	PROJECT NO: 16231
DRAWN BY: AH5	SHEET NO: L-1
CHECKED BY: MWM	
DATE: 7/27/2016	
DATE OF PRINT: 8/15/2016	